


Boston
Buffalo
Jacksonville
Los Angeles
New York
St. Louis
Washington

3299 K Street, N.W., Suite 500
Washington, D.C. 20007-4415
202-337-6022

2170 Whitehaven Road
Buffalo, New York 14072
716-773-6800

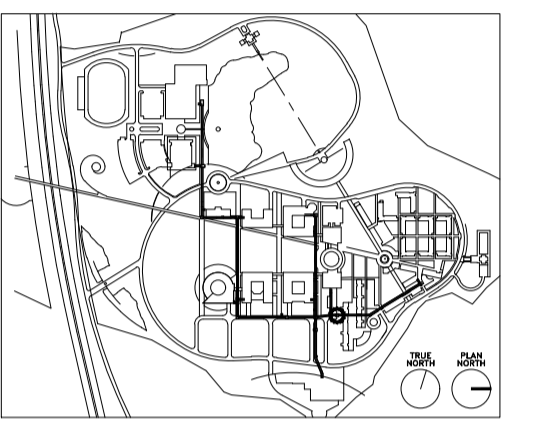

CONSTRUCTION DOCUMENTS

ASSOCIATE ARCHITECT :
PIRAMIT
LEVAZIMI SUBAYLARI SİTESİ YANII
BİRKENT SİTESİ A.BLOK D:1-2-3-4
80670 LEVENT, İSTANBUL, TURKEY.

STRUCTURAL ENGINEER :
BALKAR ENGINEERING BUREAU
EBULLA MARDİN CAD. NO:7
80620 1.LEVENT, İSTANBUL, TURKEY.

MECHANICAL ENGINEER :
BİRKİM MÜHENDİSLİK PROJE LTD.
BAYAR CAD. 103/A DEMİRKAYA İS. MERKEZİ
KAT. 3. KOZYATAGI, İSTANBUL, TURKEY.

ELECTRICAL ENGINEER :
CECELEC-AEG SYSTEM AND AUTOMATION
BALMUMCU MURBASAN SOK. AEG BİNASI
80700 BESİKTAŞ / İSTANBUL

CIVIL ENGINEER :
BARTEK
MÜHENDİSLİK TAHHÜT, ETHEM EFENDİ CD.
FİRİN SOK. BAHAH APT. NO. 18/7
81060 ERENKÖY İSTANBUL, TURKEY.

CONTRACTOR :
KORAY
YAPI İNŞAAT VE TİCARET A.Ş.
BUYUKDERE CD.YAPI KREDİ PLAZA C BLOK
KAT 19 80620 LEVENT İSTANBUL, TURKEY.

SUB-CONTRACTOR :
aktif
ELEKTRİK MÜHENDİSLİK, MÜTEAHHİTLİK
SAN. ve TİC. LTD. ŞTİ.
SÜLÜN SOKAK NO:26 80620 1.LEVENT-İST.
TEL: 0212 2799470 FAX: 0212 2827963

Scale 1/50

Revision	by	Date	İnş	Remarks	Adres
1					
2					
3					

Issue Date 02.04.2004
Drawing Title 1. Kat

SPORT CENTER
FIRST LEVEL
LIGHTING PLAN


SPOR SALONU
1.KAT
AYDINLATMA PLANI

Designed by İnan
Drawn by İnan İLKER CANBAZ
Checked by İnan MURAT PULAT
Approval İnan HİKMET SARISU
Project No. Proje No SC-AS-203wg
Scale 1 : 100
Drawing No. Çim No

SEMBOLLER SYMBOLS	TURKÇE AÇIKLAMA TURKISH DESCRIPTION	İNGİLİZCE AÇIKLAMA ENGLISH DESCRIPTION	MİKTAR QUANTITY
●	J1-TC-D 1x26 W (SIVA ALTI AYDINLATMA ARMATÜRÜ) CAMLI J1-TC-D 1x26W (FLUSH - MOUNTED LIGHTING FIXTURE) WITH GLASS		-
⊙	J2-TC-D 2x18 W (SIVA ALTI AYDINLATMA ARMATÜRÜ) J2-TC-D 2x18 W (FLUSH - MOUNTED LIGHTING FIXTURE)		-
⊖	J3-TC-D 2x26 W (SIVA ALTI AYDINLATMA ARMATÜRÜ) J3-TC-D 2x26 W (FLUSH - MOUNTED LIGHTING FIXTURE)		-
○	DD1 12/50 W HALOGEN (SIVA ALTI AYDINLATMA ARMATÜRÜ) DD1 12/50 W HALOGEN (FLUSH - MOUNTED LIGHTING FIXTURE)		-
⊖	1X150 W ASKILI AYDINLATMA ARMATÜRÜ 1X150 W PENDANT LIGHTING FIXTURE		-
○	1X70 W (SIVA ALTI AYDINLATMA ARMATÜRÜ) 1X70 W (FLUSH - MOUNTED LIGHTING FIXTURE)		-
□	S1-1-05 4x18 W (SIVA ALTI AYDINLATMA ARMATÜRÜ) S1-1-05 4x18 W (FLUSH - MOUNTED LIGHTING FIXTURE)		-
□	S3-1-05 2(2x36 W) ASKILI AYDINLATMA ARMATÜRÜ S3-1-05 2(2x36 W) PENDANT LIGHTING FIXTURE		-
□	S4-1-05 3(2x36 W) ASKILI AYDINLATMA ARMATÜRÜ S4-1-05 3(2x36 W) PENDANT LIGHTING FIXTURE		-
⚡	KILIC ARMATÜR		-
⊖	EX1 116 1x8 W (SIVA ÜSTÜ, DUVAR TİPİ, ÇFT YONLU, 90 DAKIKA AKU KAPASİTELİ ÇFT ARMATÜR) EX1 116 1x8 W (SURFACE MOUNTED WALL TYPE SINGLE SIDED BATTERY CAPACITY 90 MIN/EXT LIGHT)		-
⊖	EX2 116 1x8 W (SIVA ÜSTÜ, DUVAR TİPİ, ÇFT YONLU, 90 DAKIKA AKU KAPASİTELİ ÇFT ARMATÜR) EX2 116 1x8 W (SURFACE MOUNTED WALL TYPE DOUBLE SIDED BATTERY CAPACITY 90 MIN/EXT LIGHT)		-
⊖	EX3 116 1x8 W (SIVA ÜSTÜ, TAVAN TİPİ, ÇFT YONLU, 90 DAKIKA AKU KAPASİTELİ ÇFT ARMATÜR) EX3 116 1x8 W (SURFACE MOUNTED CEILING TYPE DOUBLE SIDED BATTERY CAPACITY 90 MIN/EXT LIGHT)		-
⊖	EX4 116 1x8 W (SIVA ÜSTÜ, TAVAN TİPİ, ÇFT YONLU, ÇFT YÖNELİ, 90 DAKIKA AKU KAPASİTELİ ÇFT ARMATÜR) EX4 116 1x8 W (SURFACE MOUNTED CEILING TYPE DOUBLE SIDED DOUBLE DIRECTION, BATTERY CAPACITY 90 MIN/EXT LIGHT)		-
—	T1-1x36W FLORESAN AYDINLATMA ARMATÜRÜ T1-1x36W FLUORESCENT LIGHTING FIXTURE		-
—	U-2x36 W (SIVA ÜSTÜ ETANS AYDINLATMA ARMATÜRÜ) U-2x36 W (SURFACE MOUNTED WEATHERPROOF LIGHTING FIXTURE)		-
—	U-1x36 W (SIVA ÜSTÜ ETANS AYDINLATMA ARMATÜRÜ) U-1x36 W (SURFACE MOUNTED WEATHERPROOF LIGHTING FIXTURE)		-
—	2X58 W(SIVA ALTI SQUASH ARMATÜRÜ)		-
⚡	BRİ KUTUPLU SIVA ALTI NORMAL ANAHTAR ONE POLE SWITCH, FLUSH MOUNTED		-
⚡	BRİ KUTUPLU SIVA ALTI KOMUTATÖR ANAHTAR ONE POLE CHANGE OVER SWITCH, FLUSH MOUNTED		-
⚡	BRİ KUTUPLU SIVA ALTI VAVİYEN ANAHTAR ONE POLE 3 WAY SWITCH, FLUSH MOUNTED		-
⚡	BRİ KUTUPLU SIVA ALTI YAYLI ANAHTAR ONE POLE SNAP SWITCH, FLUSH MOUNTED		-
⚡	BRİ KUTUPLU SIVA ALTI DİMER ONE POLE FLUSH MOUNTED DIMMER		-
⚡	BRİ KUTUPLU SIVA ÜSTÜ ETANS ANAHTAR DİMER ONE POLE, SURFACE MOUNTED, WEATHER PROOF SWITCH		-
⚡	BRİ KUTUPLU SIVA ÜSTÜ ETANS KOMUTATÖR ANAHTAR ONE POLE, SURFACE MOUNTED, W.P. CHANGE OVER SWITCH		-
⚡	BRİ KUTUPLU SIVA ÜSTÜ ETANS VAVİYEN ANAHTAR ONE POLE, SURFACE MOUNTED, WEATHER PROOF 3 WAY SWITCH		-
⚡	BRİ KUTUPLU SIVA ÜSTÜ ETANS YAYLI ANAHTAR ONE POLE, SURFACE MOUNTED, WEATHER PROOF SNAP SWITCH		-
⚡	BRİ KUTUPLU SIVA ALTI DİMER VAVİYEN ANAHTAR ONE POLE 3 WAY DIMMER, FLUSH MOUNTED		-
■	AYDINLATMA TABLOSU LIGHTING PANEL		-
■	GAUZEK AYDINLATMASI UPS TABLOSU SECURITY LIGHTING UPS PANEL		-
■	1X400 W PROJİKTÖR		-

X (Y -Z- R)
X: GRUP
Y: LİNYE NO
Z: ARMATÜR NO
R: FAZ

PANODAKI KONUMLAR
TV MODUNDA --- A, B, C, D, E, F grupları yanmaktadır.(1500-1750 lux dikey)
ANTREMAN MODUNDA --- E, F grupları yanmaktadır.(750-1000 lux yatay)
MUSABAKA MODUNDA --- B, C, D, E, F grupları yanmaktadır.(1500-2000 yatay)
SOL ANTREMAN MODUNDA --- C, E grupları yanmaktadır.(300-500 lux yatay)
SAG ANTREMAN MODUNDA --- D, F grupları yanmaktadır.(300-500 lux yatay)

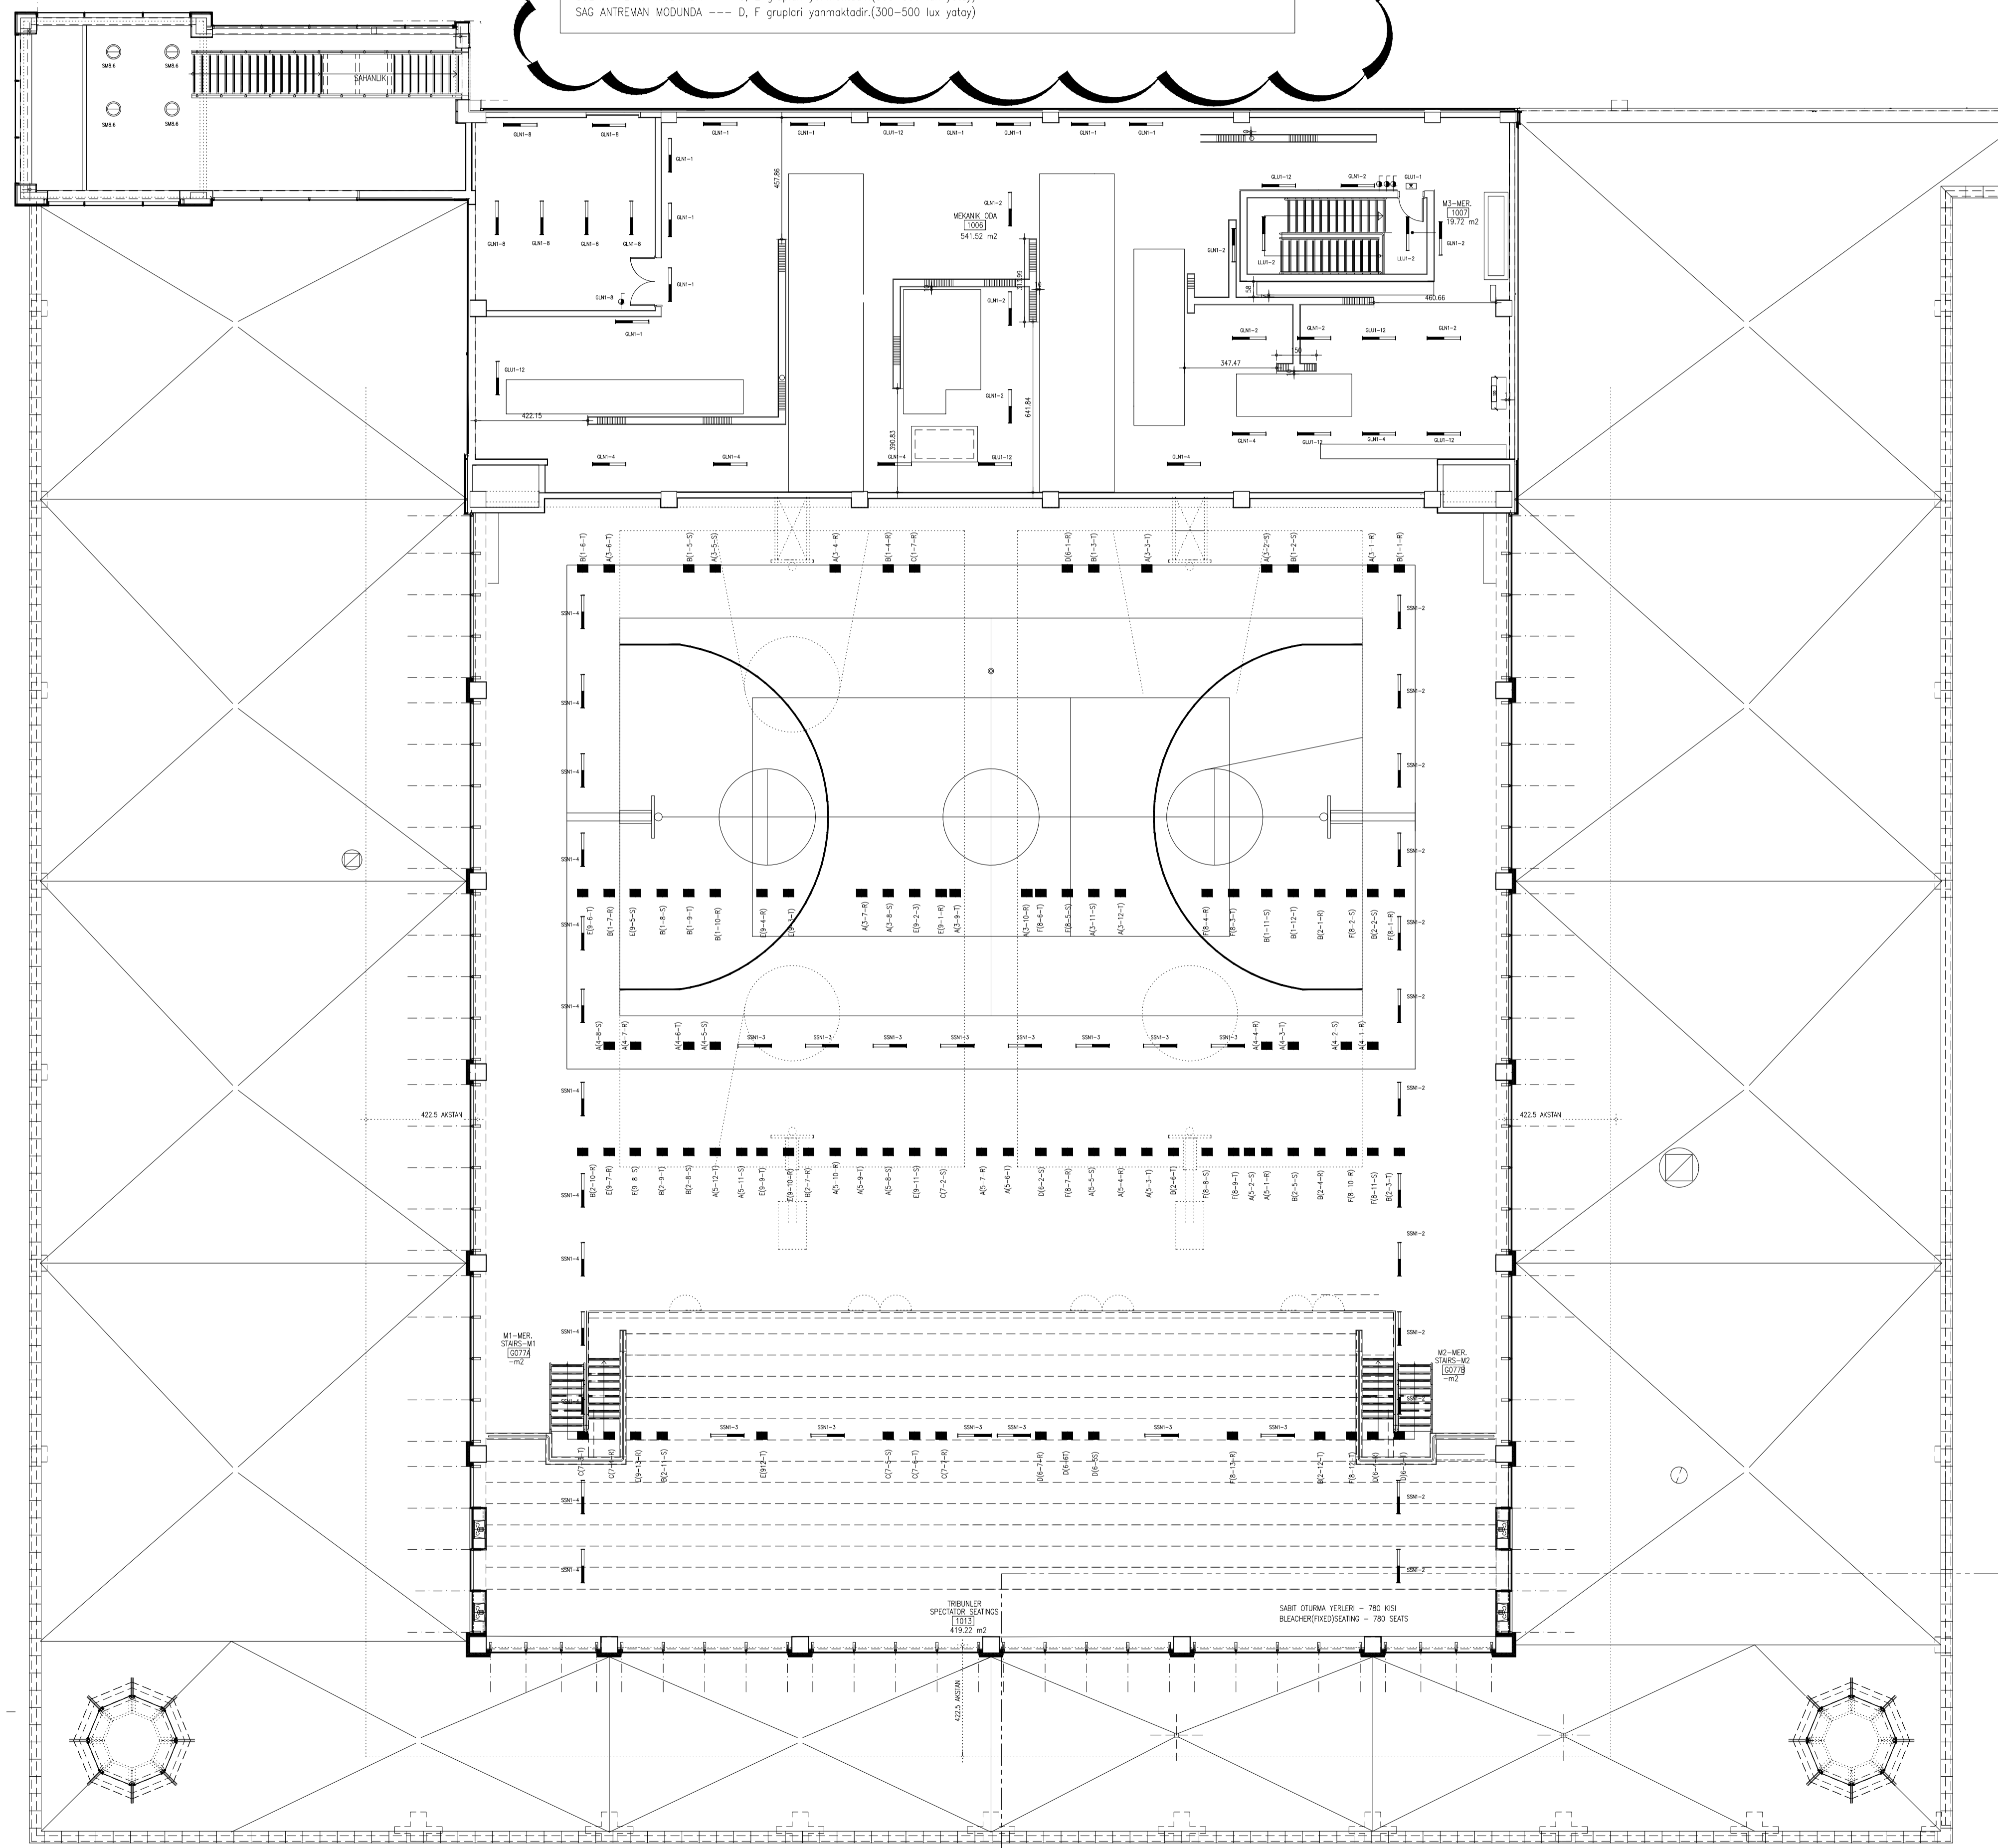

1. KAT AYDINLATMA PLANI
FIRST FLOOR LIGHTING PLAN